


REVISIONS

ZONE	No.	DESCRIPTION	DATE	APPROVED

LEGEND

- NEEDLE VALVE
- HAND VALVE
- SOLENOID VALVE
- CHECK VALVE
- PILOT OPERATED SOLENOID VALVE
- CONSTANT PRESSURE VALVE
- BALL VALVE
- PRESSURE REGULATOR WITH PRESSURE INDICATOR
- PRESSURE REDUCING VALVE
- FILTER
- PRESSURE INDICATOR
- TEMPERATURE TRANSMITTER
- CONTACT FOR MAX MOTOR TEMPERATURE
- TEMPERATURE SENSOR
- SPEED SENSOR
- TIMING UNIT
- PRODUCT LINE
- ELECTRICAL LINE
- LOW VOLTAGE LINE
- PREPARED
- NOT SUPPLIED BY CENTRICO
- TO TIMING UNIT

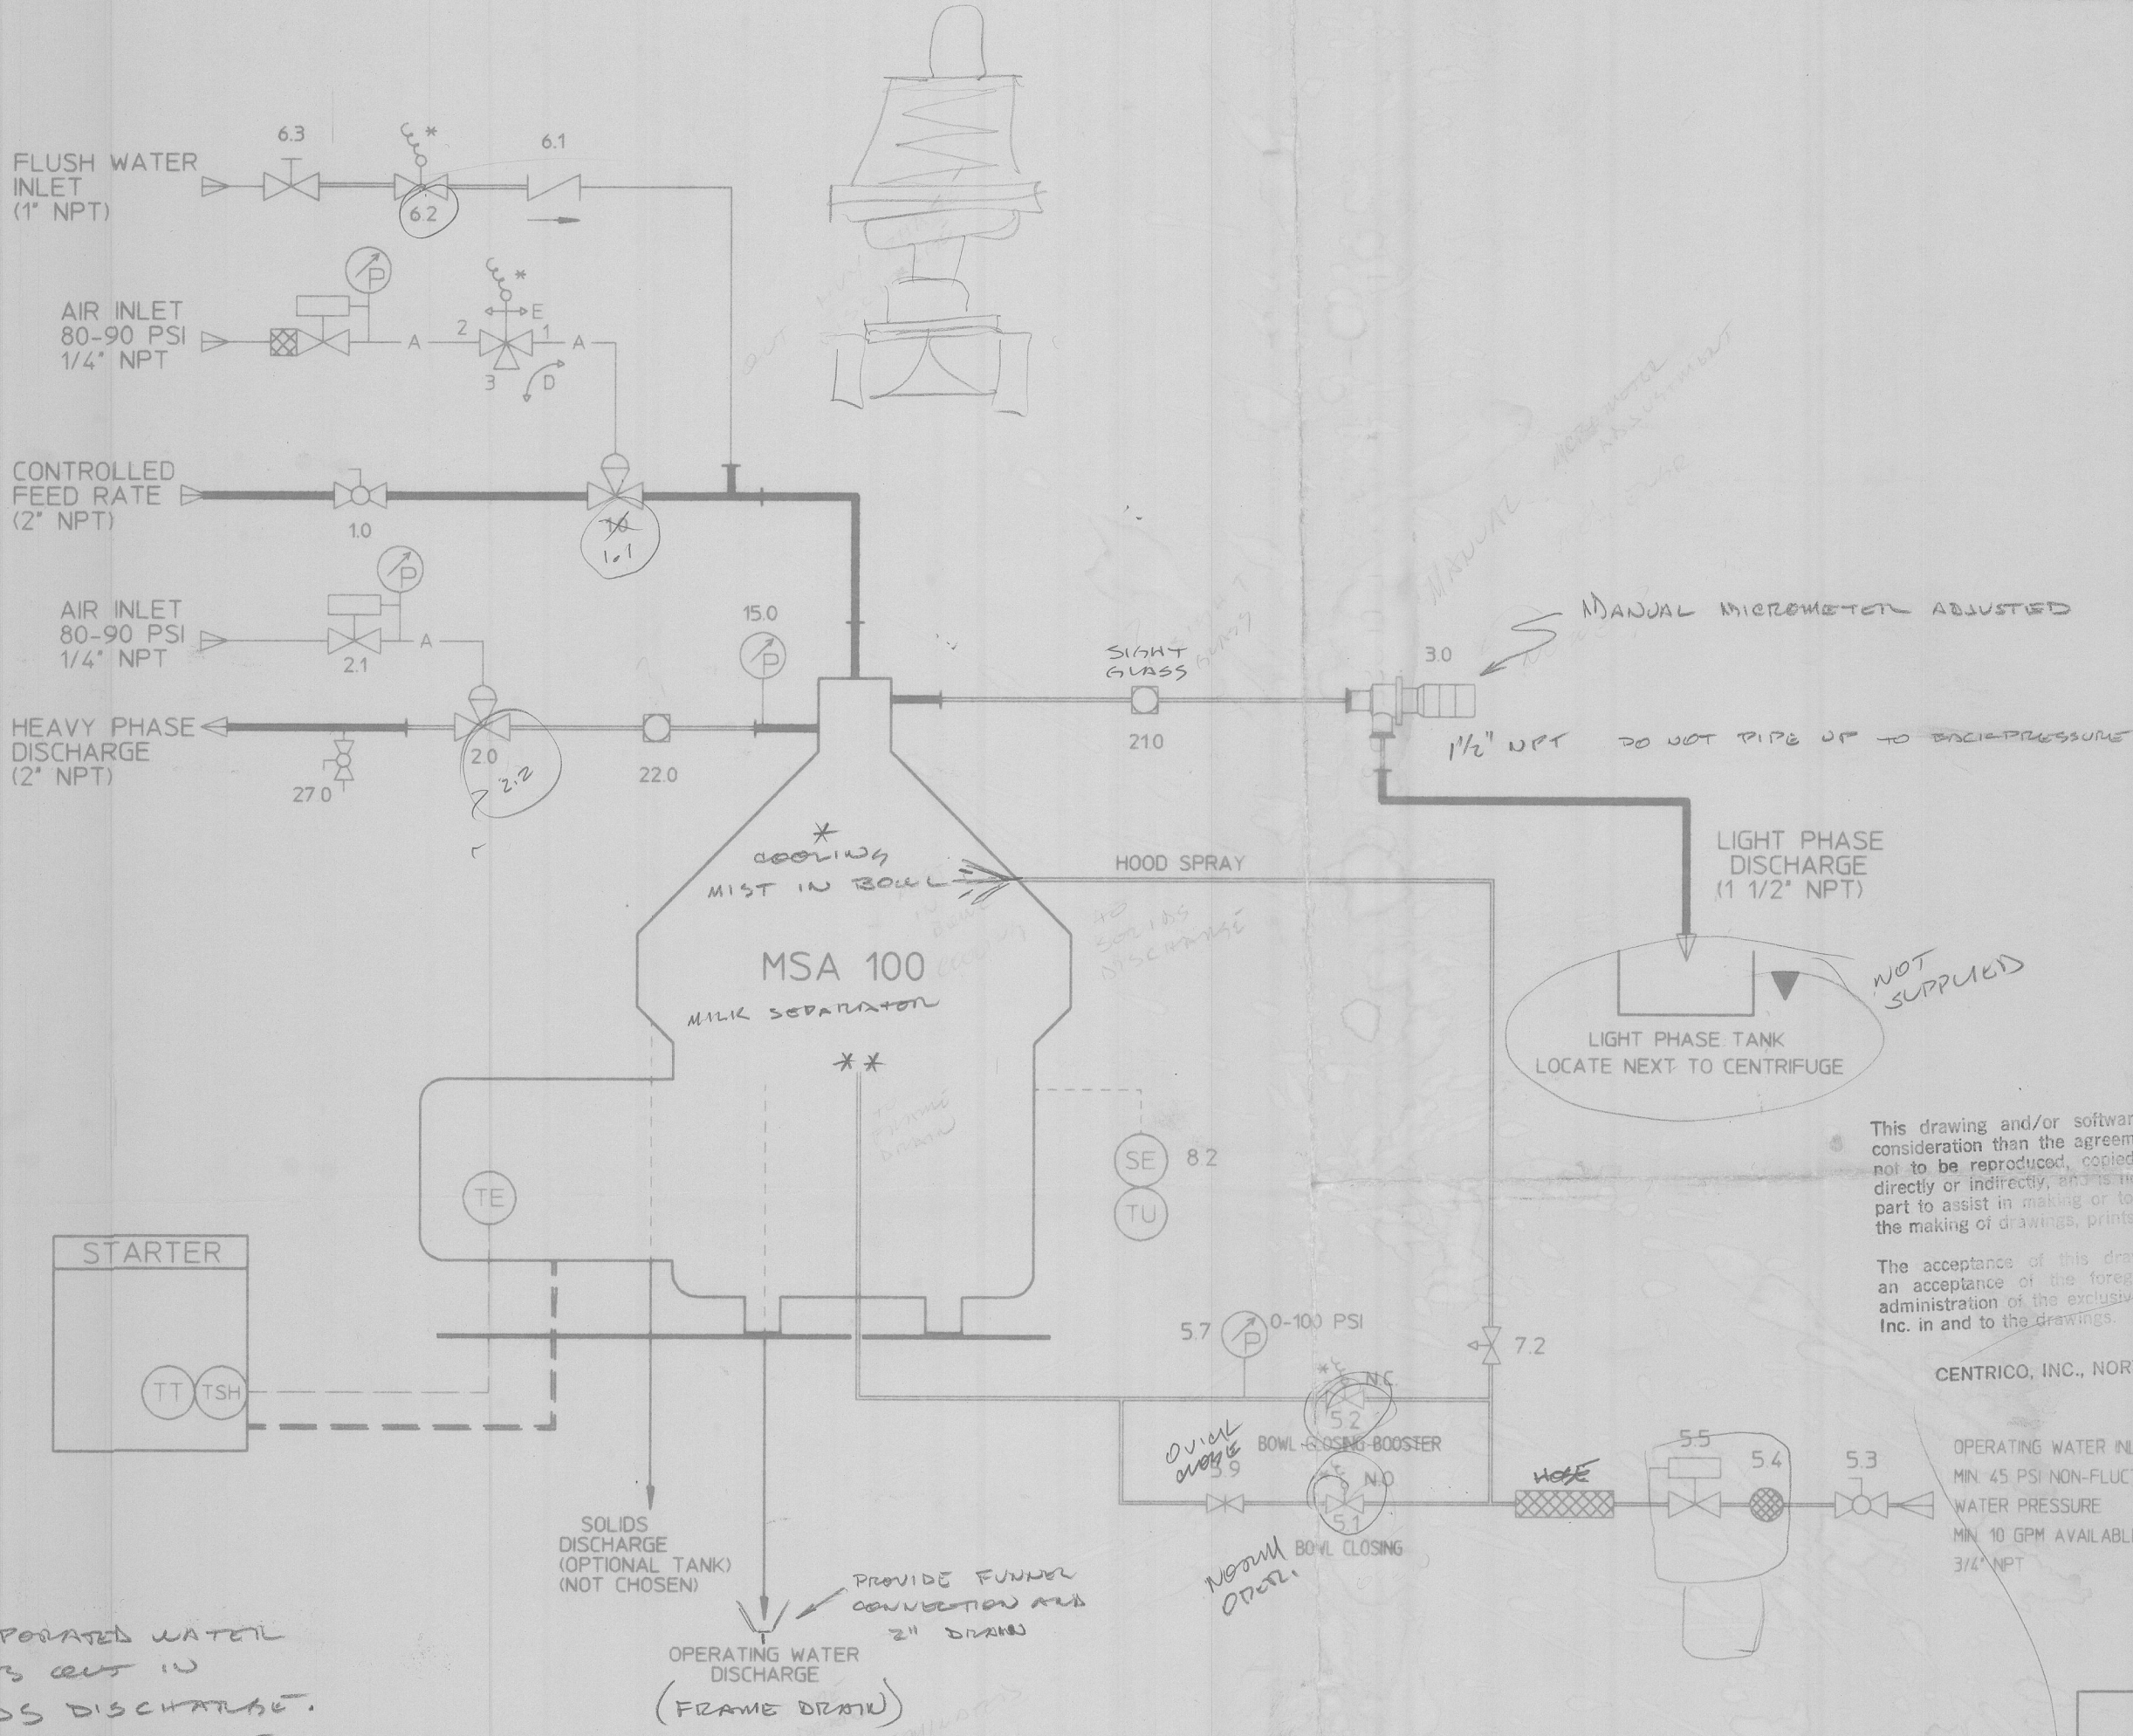

This drawing and/or software is loaned without other consideration than the agreement and condition that it is not to be reproduced, copied or otherwise disposed of, directly or indirectly, and is not to be used in whole or in part to assist in making or to furnish any information for the making of drawings, prints, apparatus or parts thereof.

The acceptance of this drawing will be construed as an acceptance of the foregoing conditions and as an administration of the exclusive ownership of the Centrico, Inc. in and to the drawings.

CENTRICO, INC., NORTHVALE, NEW JERSEY

OPERATING WATER INLET
MIN 45 PSI NON-FLUCTUATING
WATER PRESSURE
MIN 10 GPM AVAILABLE ~ 2 GPM CONTINUOUS
3/4" NPT

SEE INSTALLATION PLAN
DRAWING FOR OPTIONALS
I AND II

ETU WIRING DIAGRAM	9128-5900-133
STARTER WIRING DIAGRAM	9210-5900-C91
FOUNDATION DETAIL	1231-02
INSTALLATION PLAN	9140-4100-025
DESCRIPTION	DRAWING NUMBER

LIST OF REFERENCE DRAWINGS

11-009	606W75650	ARISTECH CHEMICAL CORP	ORGANIC OIL FROM WATER	MSA 100	1
CENTRICO NUMBER	CUSTOMER NUMBER	CUSTOMER	END USE	MACHINE	QTY

Submitted Date	
Drawn	S.M.D.
Checked	H-
Approved	PB-
Hull No.	
Purchase Order No.	
Final Approval	

WESTFALIA SEPARATOR
100 Fairway Court Northvale, New Jersey 07647

CENTRICO
incorporated

PIPING & INSTRUMENTATION DIAGRAM
MSA 100-01-076/REC
MILK SEPARATOR - GENERATION 'A'

Size: C F S C H No. Dwg No. 9140-5700-144 Rev 0

PRODUCT PIPING BY OTHERS
ARRANGE PIPING TO ALLOW FOR REMOVAL OF BOWL TOP.
480 V, 3Ø, 60 HZ.

ITEM No.	DESCRIPTION	ADJUSTMENT	REMARKS
SETTINGS & ADJUSTMENTS RELIEF VALVES & INSTRUMENTATION			