


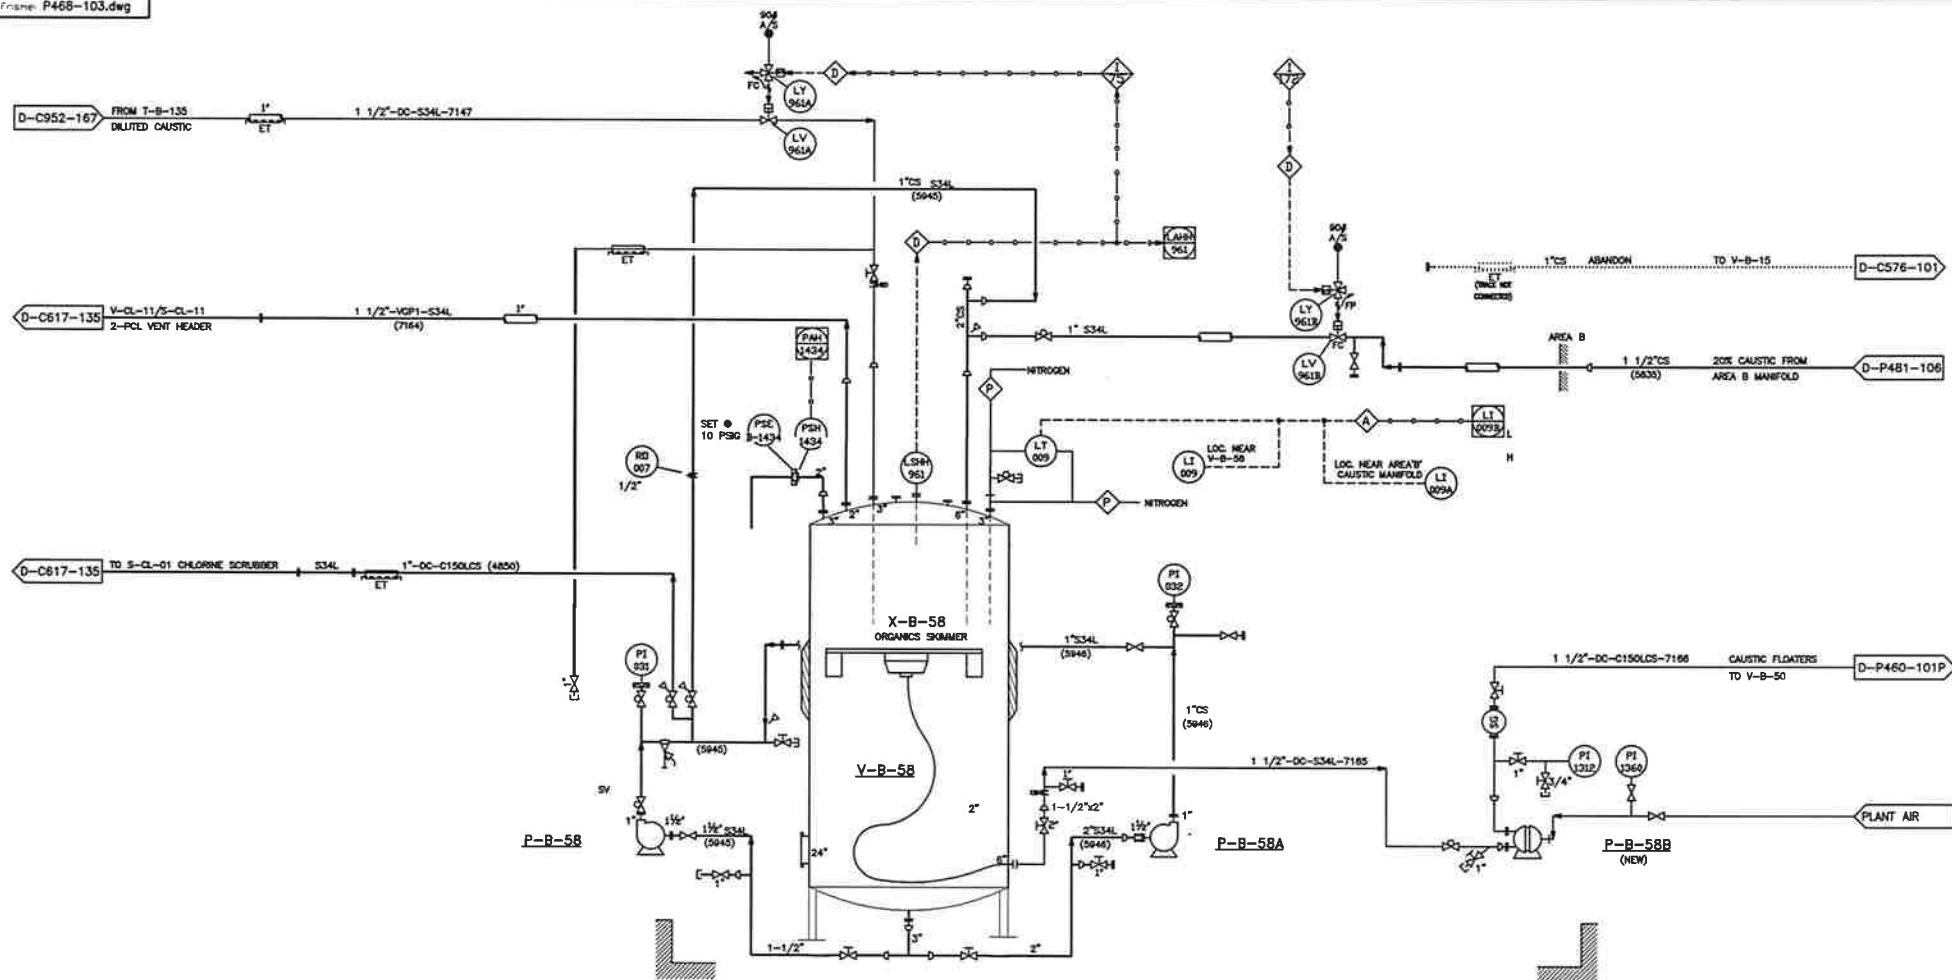

V-B-58
DILUTE CAUSTIC STORAGE
5000 GAL. 304L SS
7'-6" DIA. X 13'-10" SS
RATED @ 10 PSIG @ 250 DEG. F.

P-B-58
NEUTRALIZER FEED PUMP
GOULDS 3196 ST, 318 SS
1 X 1.5 -6, 3.5" IMPELLER
25 GPM @ 55' HEAD

P-B-58A
NEUTRALIZER FEED PUMP
GOULDS 3196 ST, CS
1 X 1.5 -6, 3.5" IMPELLER
25 GPM @ 55' HEAD

P-B-58B
CAUSTIC FLOATERS PUMP
MFG. : WARREN-RUPP CAPACITY 10 GPM @ 82' TDH
MODEL NO. : SANDPIPER PB1-A AR-POWERED
SIZE : 1" DOUBLE-DIAPHRAGM
MOC : POLYPROPYLENE

X-B-58
INTERNAL SKIMMER
CIRCULAR WEB
12" DIA. W/2" BARB
MOC : SS

9	UPDATED AS BUILT, DESCRIPTIONS & GENERAL PIPING CORRECTIONS	DAP	2/2/01	DRAWN BY	Brian D. Trepp		2PCL PROCESS V-B-58 20% CAUSTIC HOLDING TANK PIPING AND INSTRUMENTATION DIAGRAM	PROJECT NO : 548 RD SCALE : NONE DRAWING NO : D-P468-103 REV : 9
8	CHANGED V-B-58 BUPTURE GASK TAG TO PFC-B-155A, ADDED ALARM WIRE NOTE	DAP	1/23/00					
7	REMOVED LINE 4832 TO V-B-131	DMB	5/24/00					
6D	PIPING REVISION PER DESIGN REVIEW	WAW	11/15/99					
6C	ADDED INTERLOCK CHANGES	RSP	8/02/98					
REV.	DESCRIPTION	BY	DATE	APPR.				