




MATERIAL SPECIFICATION		DESIGN DATA	
SHELL	SA240-316L ✓	DESIGN CODE	ASME SECT. VIII
HEADS	SA240-316L	SERVICE	MIBK EVAP
SUPPORTS	SA240-316L	DESIGN PRESS (PSIG)	15 ✓
FLANGES	SA-182-F-316L	DESIGN TEMP (°F)	300 ✓
PIPE	SA-312-TP-316L	MAWP	15 PSI / FULL VAC. 4
BOLTS	G-B8	HYDRO TEST PRESS.	22.5
NUTS	G-B8	CORROSION ALLOW.	0
GASKETS	GARLOCK 3000 WITH TEFLON ENVELOPE	RADIOGRAPHY	SPOT
BILL OF MATERIALS		PWHT	
		WEIGHT EMPTY	
		WEIGHT TEST	
ITEM:QTY		PAINT	NONE

ITEM:QTY		DESCRIPTION						
				NOZZLE SCHEDULE				

REV	DESCRIPTION
1	RELEASE FOR CONST.
2	B2 WAS 10"; P WAS 2"; RELOCATED SUPPORT LUGS; ADDED SCAFFOLD SUPPORTS
3	ADD 1/8" & HOLES DEMISTER SUPPORT RING


M & M A DIVISION OF
HAM INDUSTRIES, INC.
PASCAGOULA, MISS.

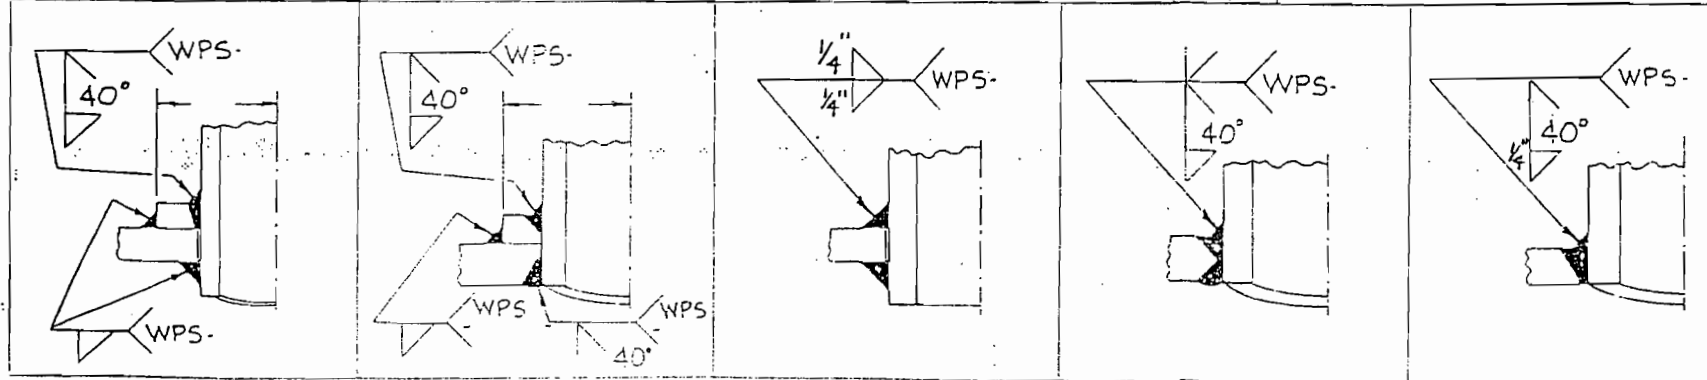





DETAIL E DETAIL D DETAIL C DETAIL B DETAIL A

MIBK EVAPORATOR	
V-812	
INDUSTRIAL DEVELOPMENT BOARD CITY OF MOBILE, AL.	
JOB: KAY-FRIES, THEODORE, AL	
CUSTOMER ORDER NO. 28-501-P0113	JOB NO. 6345
DRAWN BY SA	DATE
APPROVED BY <i>WRL</i>	DATE
DWG NO. 6345 REV 4	SCALE

99098

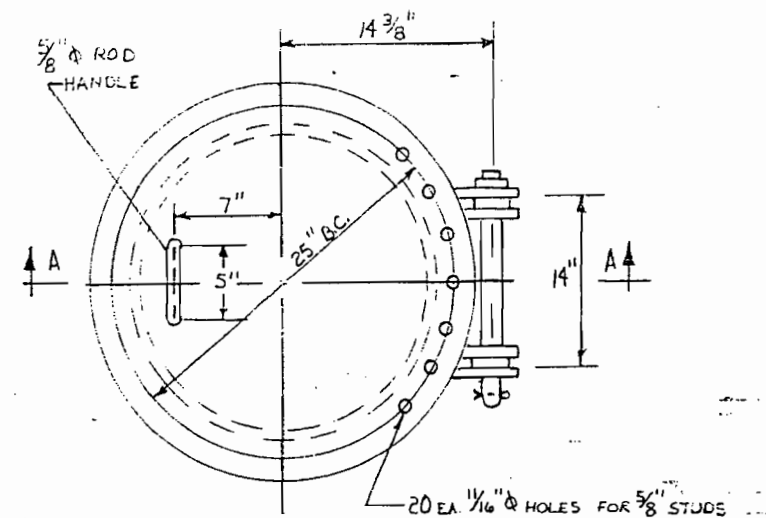

FRONT ELEVATION

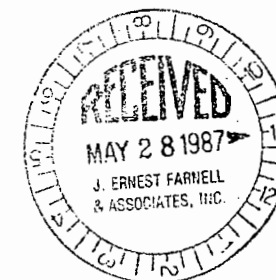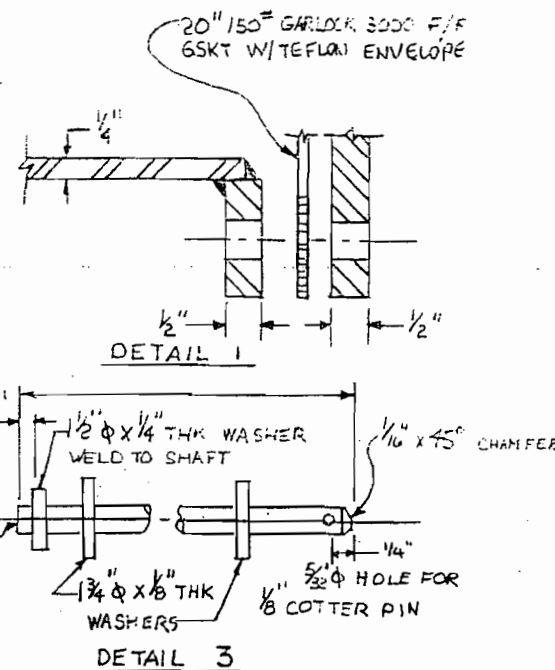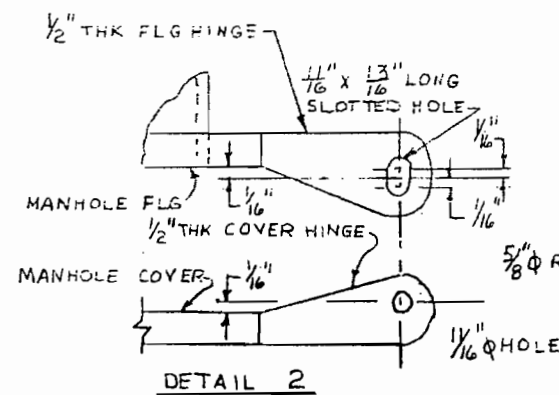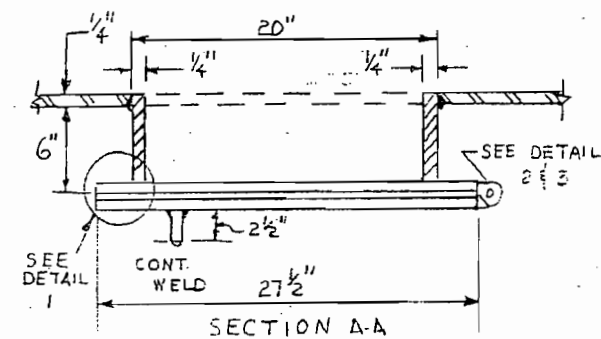


J.E. FARNELL & ASSOC., INC.
MOBILE, AL
P.O. # 28-501-P00113


INDUSTRIAL DEVELOPMENT BOARD
CITY OF MOBILE, ALABAMA
JOB: KAY-FRIES, THEODORE, AL.
M & M A DIVISION OF
HAM INDUSTRIES, INC.
PASCAGOULA, MISS.

DWG NO. 6345 REV 4 SCALE NTS
SHEET 4 OF 4

99098

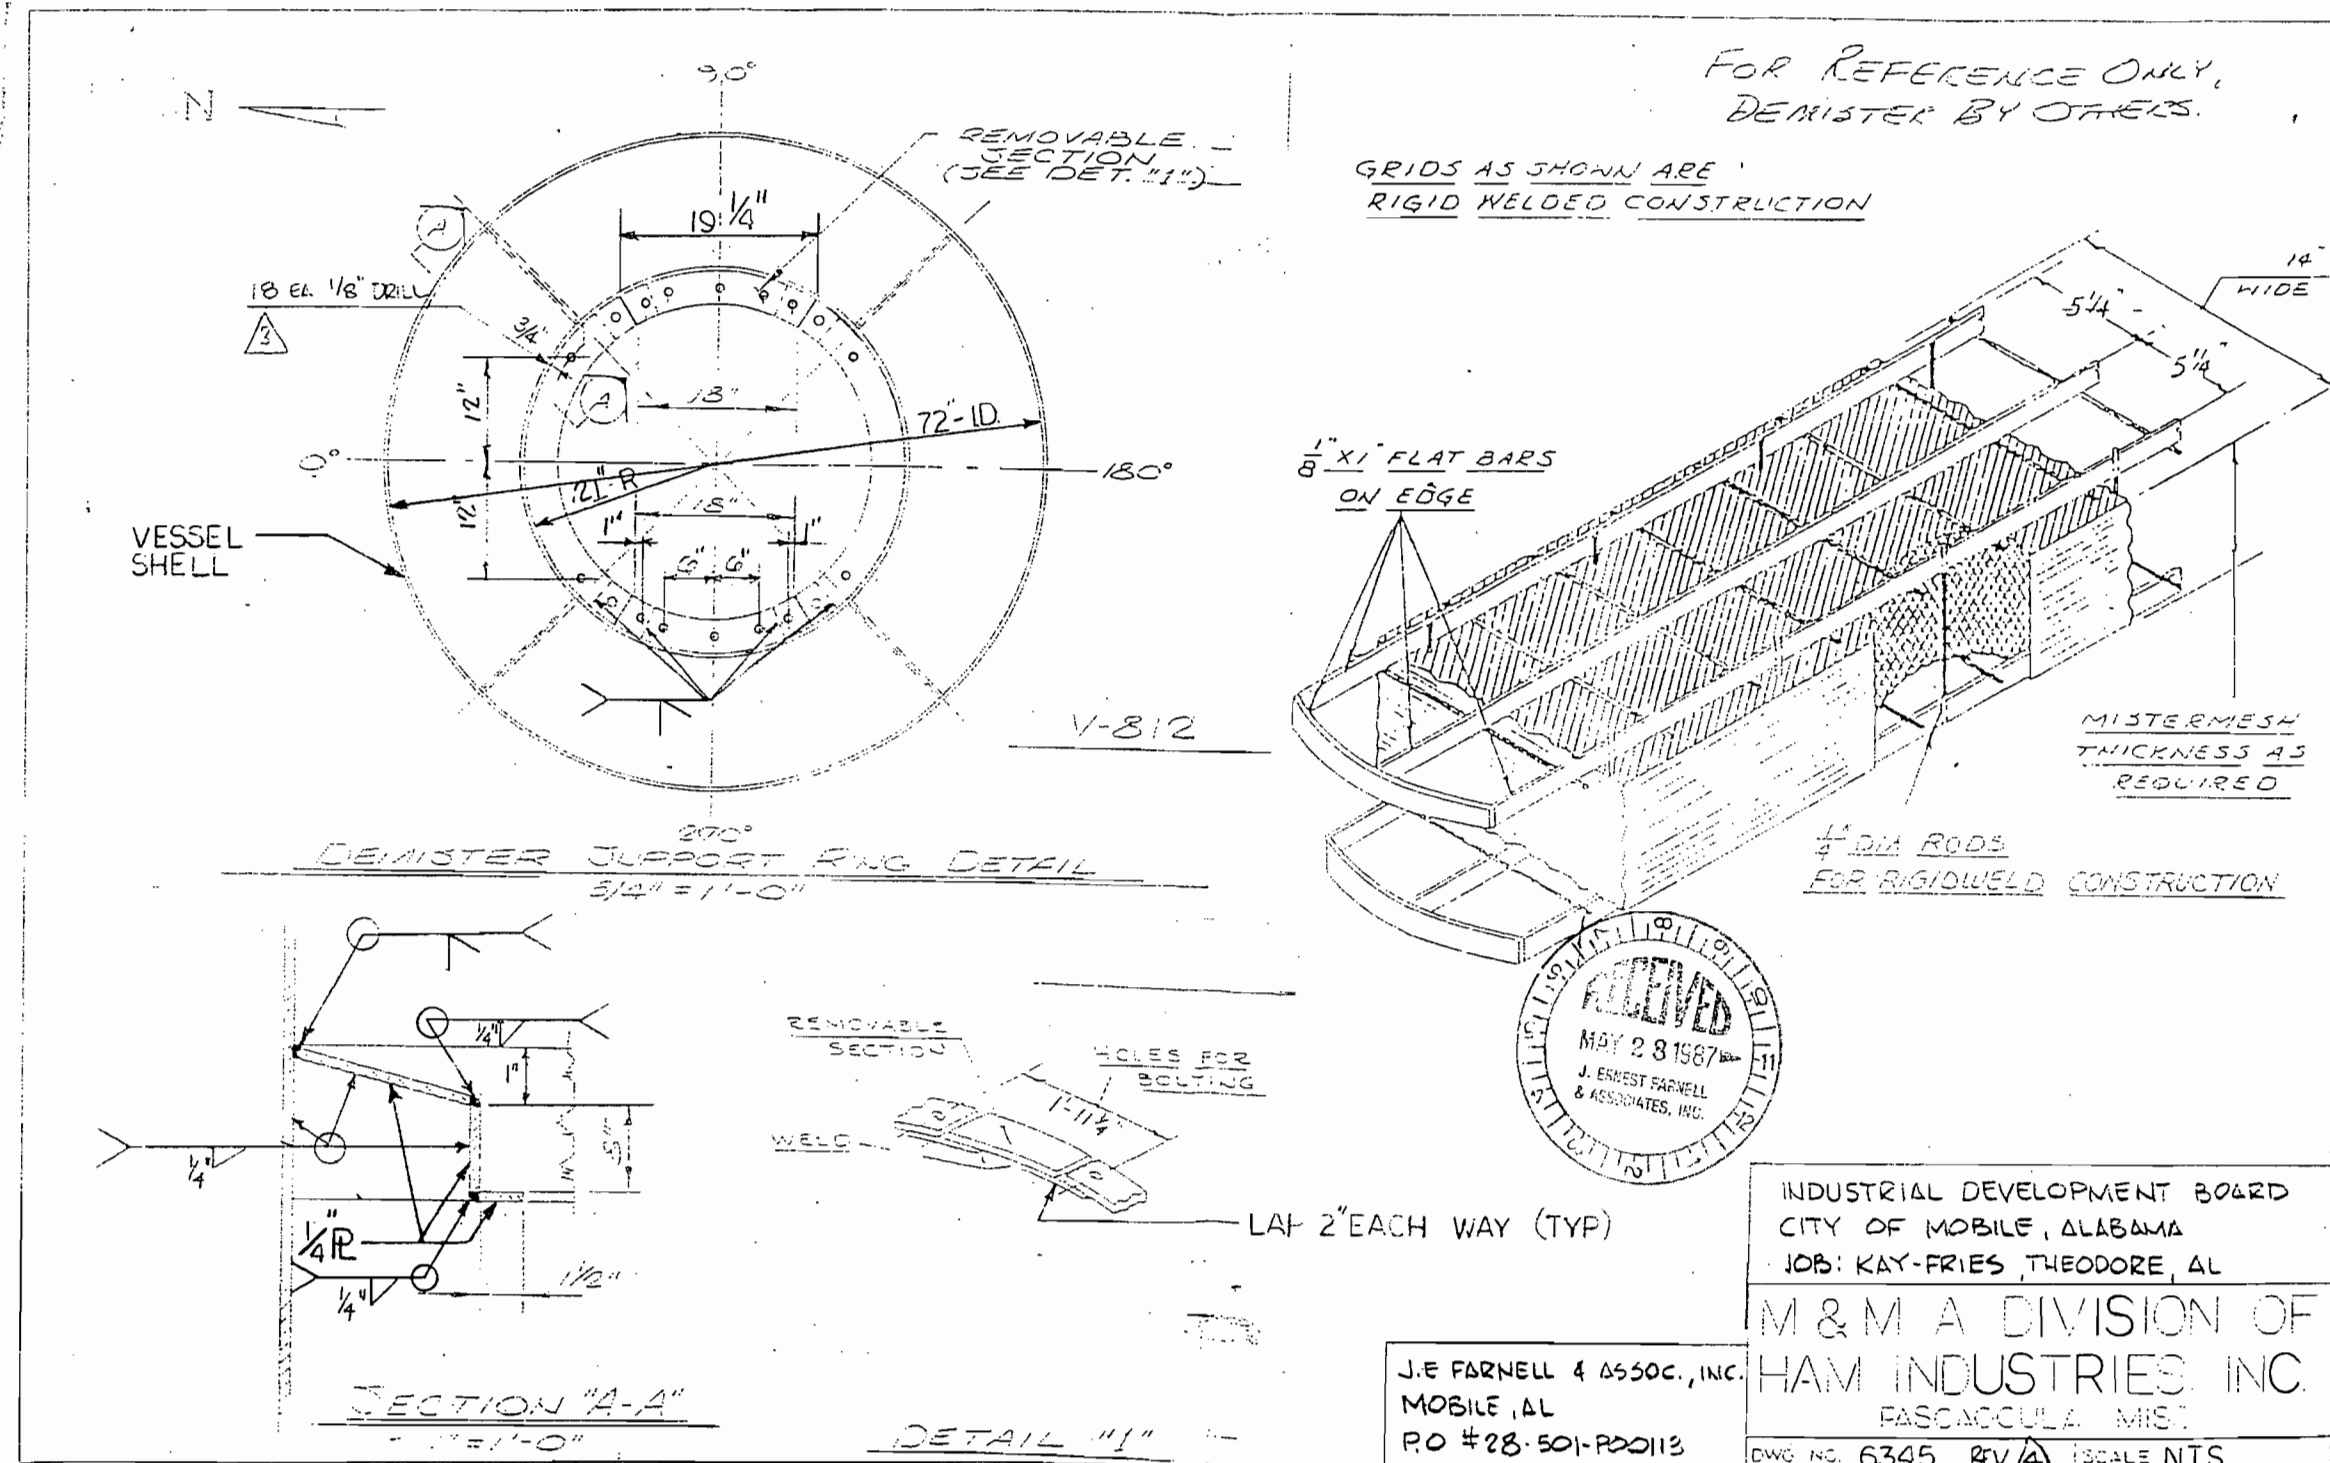

99098

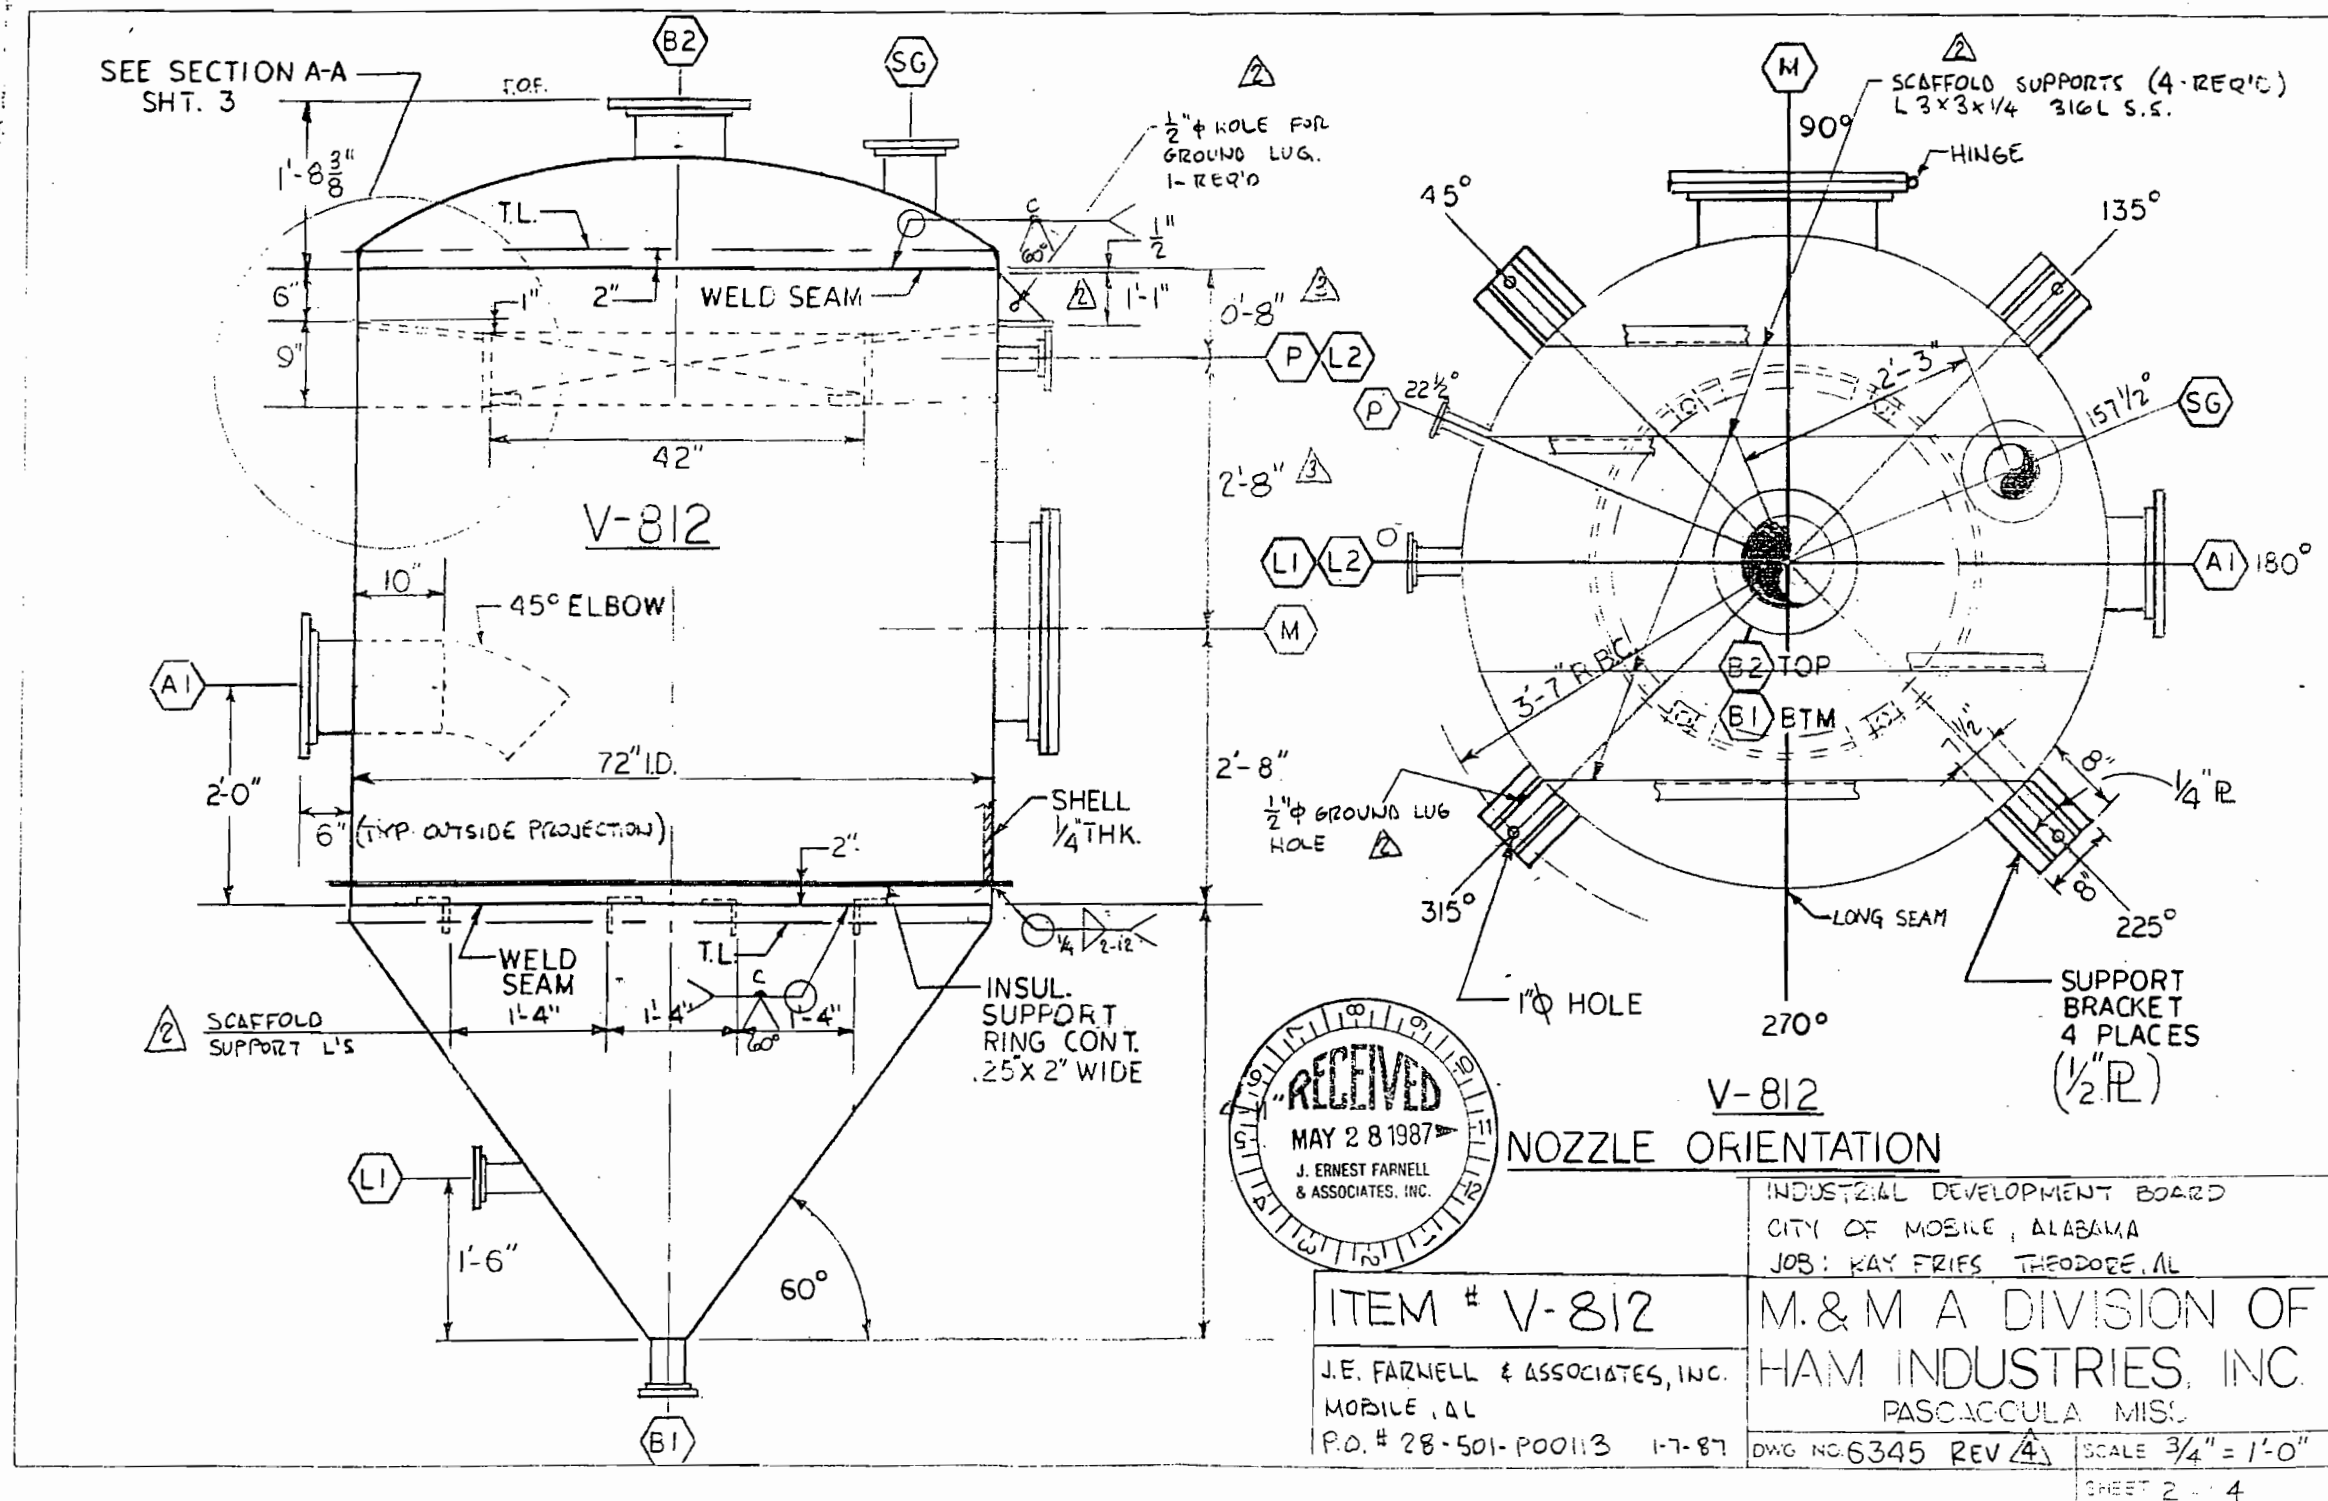

99098